
 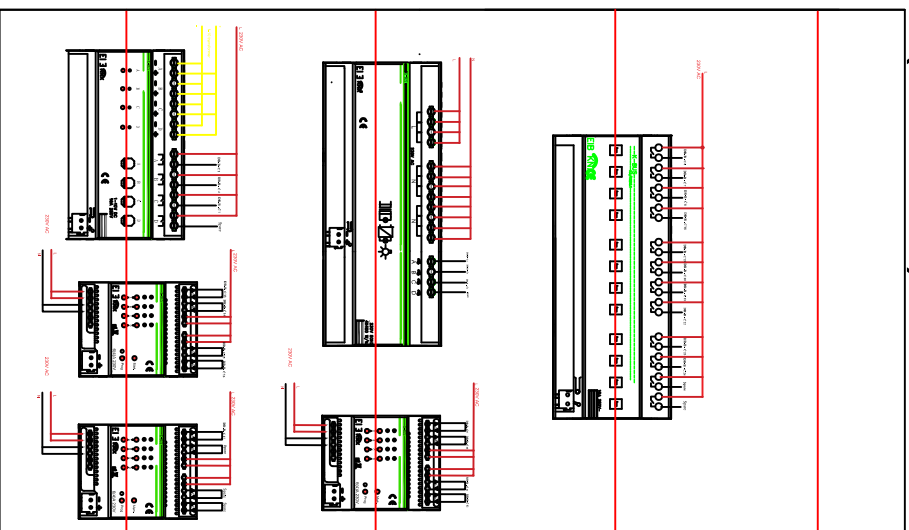
 
 
 
 
 


Basement Floor
(4 rows)



Legend	Product Name
	Switch Actuator 4 fold
	Switch Actuator 8 fold
	Switch Actuator 12 fold
	Universal Dimming Actuator 1 fold
	Universal Dimming Actuator 2 fold
	Universal Dimming Actuator 4 fold
	Dimming Controller 4 fold 1-10V
	Shutter Actuator 4 fold
	Power supply

PROJECT NAME		Mr.Ahmad Villa															
LOCATION :		Ammam		PLOT NO.		000											
PLOT AREA:		m ²		DATE:		August-2017											
CLIENT NAME																	
Mr. Ahmad Ibrahim		CONSULTANT & DESIGNER															
.signature\logo final.png		DESCRIPTION :		Low Current		DESIGNED BY :		Mohammad Alajarmeh		DRAWING NAME :		Basement FLOOR PLAN KNX-DB		SCALE : 1:100			
		PHASE:		DESIGN		CHECKED BY :		Moath Abdelrahim		6610		DRAWN BY :		Mohammad Alajarmeh			
		DWG NO.		E		P		0		1							
		NO.		REVISION										DATE			
		1		KNX-DB										15-8-2017			
2																	
3																	
4																	